


CANCER CENTER & SURGERY RELOCATION

PREPARED FOR

LAWRENCE HOSPITAL CENTER

VILLAGE OF BRONXVILLE, TOWN OF EASTCHESTER
WESTCHESTER COUNTY, NEW YORK

JUNE 2011

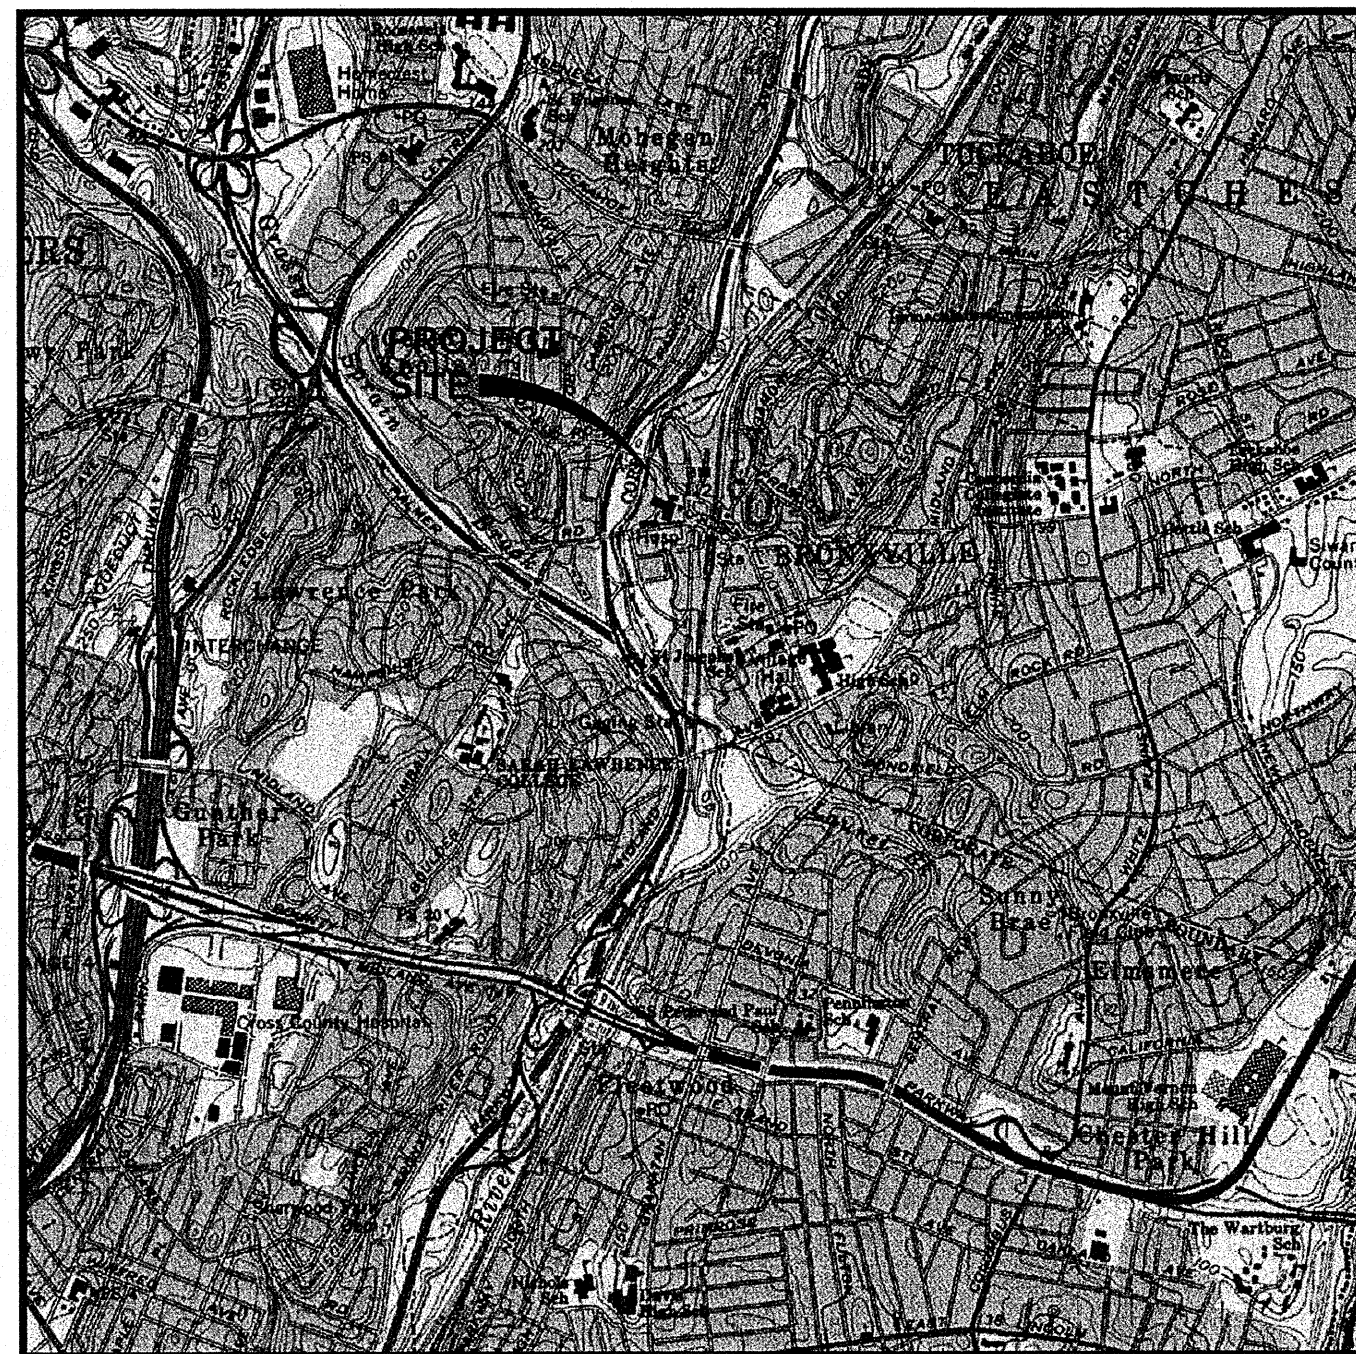

MOUNT VERNON QUADRANGLE MAP 1979

LOCATION MAP
SCALE: 1"=2000'

INDEX OF DRAWINGS		
PAGE NO.	SHEET NO.	DESCRIPTION
1	T-01	TITLE PAGE
2	C-01	EXISTING CONDITIONS PLAN
3	C-02	TREE IDENTIFICATION & REMOVAL PLAN
4	C-03	DEMOLITION PLAN
5	C-04	SITE PLAN-OVERALL
6	C-05	SITE PLAN
7	C-06	UTILITY PLAN
8	C-07	EROSION & SEDIMENT CONTROL PLAN
9	C-08	NOTES & DETAILS - EROSION & SEDIMENT CONTROL
10	C-09	WCDOH DETAILS
11	C-10	WCDOH DETAILS AND NOTES
12	C-11	SITE DETAILS AND NOTES
13	C-12	SITE DETAILS

RECORD OWNER:

LAWRENCE HOSPITAL CENTER
55 PALMER AVENUE
BRONXVILLE, NY
PHONE: (914) 787-6050

APPLICANT:

LAWRENCE HOSPITAL CENTER
55 PALMER AVENUE
BRONXVILLE, NY
PHONE: (914) 787-6050

TAX MAP INFORMATION:

VILLAGE OF BRONXVILLE, TOWN OF
EASTCHESTER
WESTCHESTER COUNTY
SECTION 2, BLOCK 5, LOTS 4 & 5

AREA:

PROPERTY ACREAGE : 3.54 ACRES
PROJECT ACREAGE : 0.73 ACRES

ARCHITECT:

LILLIBRIDGE
LHS FACILITIES DEVELOPMENT GROUP, INC.
5308 W. PLANO PKWY
PLANO, TX 75093
PHONE: (972) 248-9100

 
LANDSCAPE ARCHITECT:

MARK K. MORRISON
LANDSCAPE ARCHITECTURE, P.C.
242 W. 30TH STREET, STE. 403
NEW YORK, NY 10001
PHONE: (212) 629-9711




SITE CIVIL ENGINEER:

CHAZEN ENGINEERING & LAND SURVEYING CO., P.C.
21 FOX STREET, POUGHKEEPSIE, NY 12601
PHONE: (845) 454-3980

Dig Safely. New York
Call Before You Dig
Wait The Required Time
Confirm Utility Response
Respect The Marks
Dig With Care
800-962-7962
www.digsafelynewyork.com



1
T-01
TITLE PAGE
SCALE: AS SHOWN

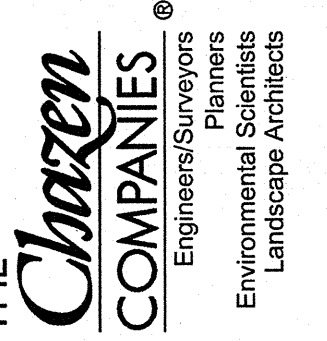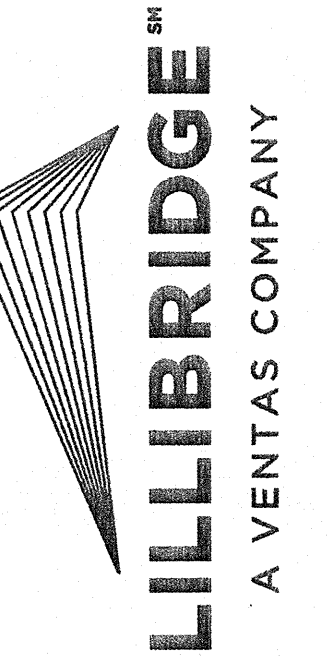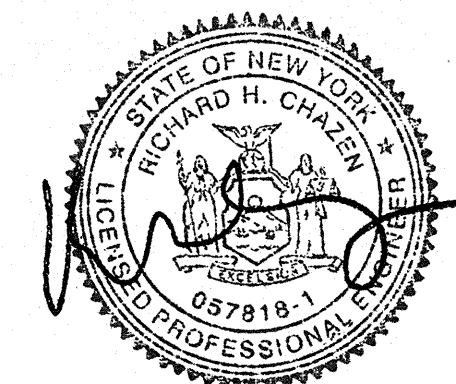

THIS DRAWING IS NOT INTENDED FOR BIDDING OR CONSTRUCTION PURPOSES.

THIS DOCUMENT IS THE PROPERTY OF LHS FACILITIES DEVELOPMENT GROUP INC. & SHALL NOT BE USED WITHOUT LHS FACILITIES DEVELOPMENT GROUP INC. EXPRESS WRITTEN CONSENT

**LAWRENCE HOSPITAL CENTER
CANCER CENTER & OPERATING ROOM RELOCATION**
55 PALMER AVENUE
BRONXVILLE, NY 10708

NO.	DATE	BY

PROJECT NO: 2009-09

DATE: 03/22/2011

DRAWN BY: SD/MM/GC

SHEET NO.

T-01